


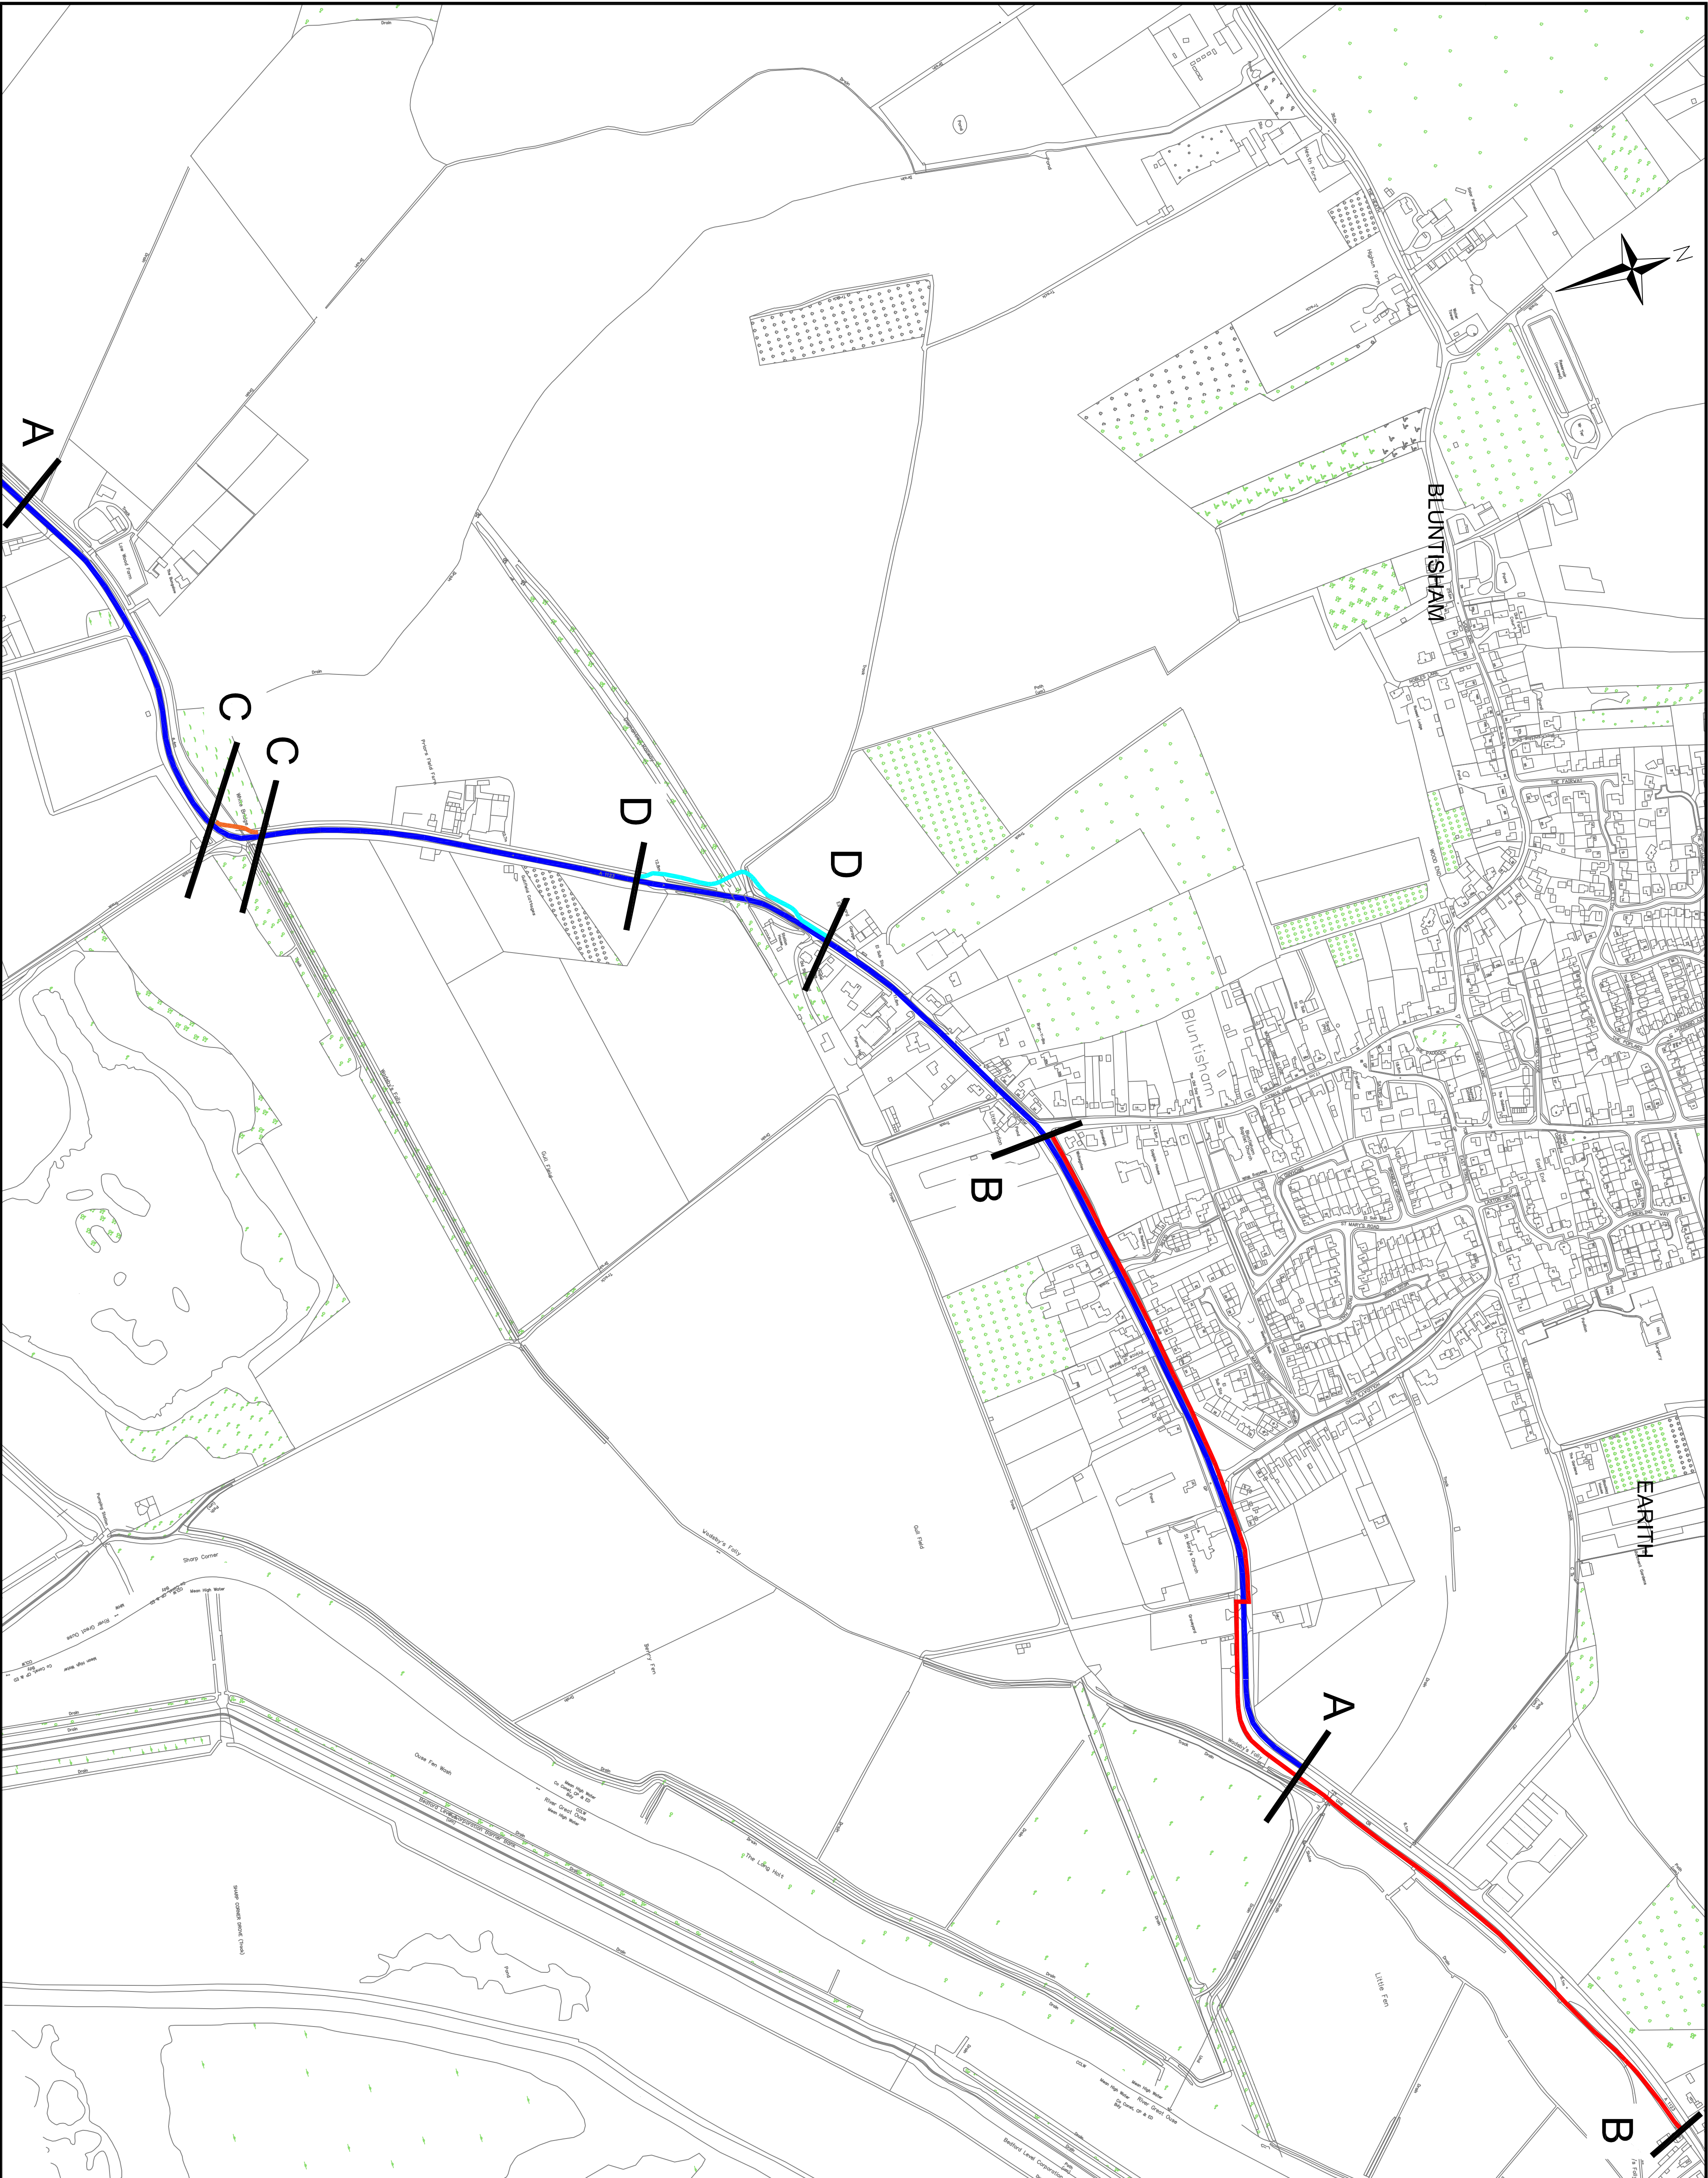

Notes

Resurfacing

A-A

A1123 Bluntisham
16,270 sq.m
Resurface carriageway and replace all road markings.
12/03/18 - 23/03/18
ROAD CLOSURE - 8:30pm - 6:00am

Cycleway

B-B

Bluntisham to Earith
1,400 m
Widen footway, amend junctions, install pedestrian/cycle traffic islands.
29/01/18 - 18/05/18
TRAFFIC LIGHTS

C-C

White Bridge
Install prefabricated bridge over ditch.
22/01/18 - 09/03/18
TRAFFIC LIGHTS

12/03/18 - 23/03/18
ROAD CLOSURE - 8:30pm - 6:00am

D-D

Bluntisham Link - Cutting
Fill cutting, culvert ditches and install cycleway.
06/11/17 - 13/04/18
TRAFFIC LIGHTS

NOTE

Please visit the dedicated webpage as dates and times may have been updated:
www.cambridgeshire.gov.uk/bluntisham-earith-cycleway

Date	Ref.	Revisions
------	------	-----------



Project
Bluntisham & Earith
Highway Projects

Title
Communications Plan
Residents Letter

Scale	Drawn	Checked	Date
NTS	SP		13/12/17
Based upon Ordnance Survey material with the permission of the controller of Her Majesty's Stationary Office. Unauthorised reproduction of this material is prohibited. Crown Copyright and database rights (2015) Ordnance Survey 100023216			
Drawing number	16313-0000-000A		